
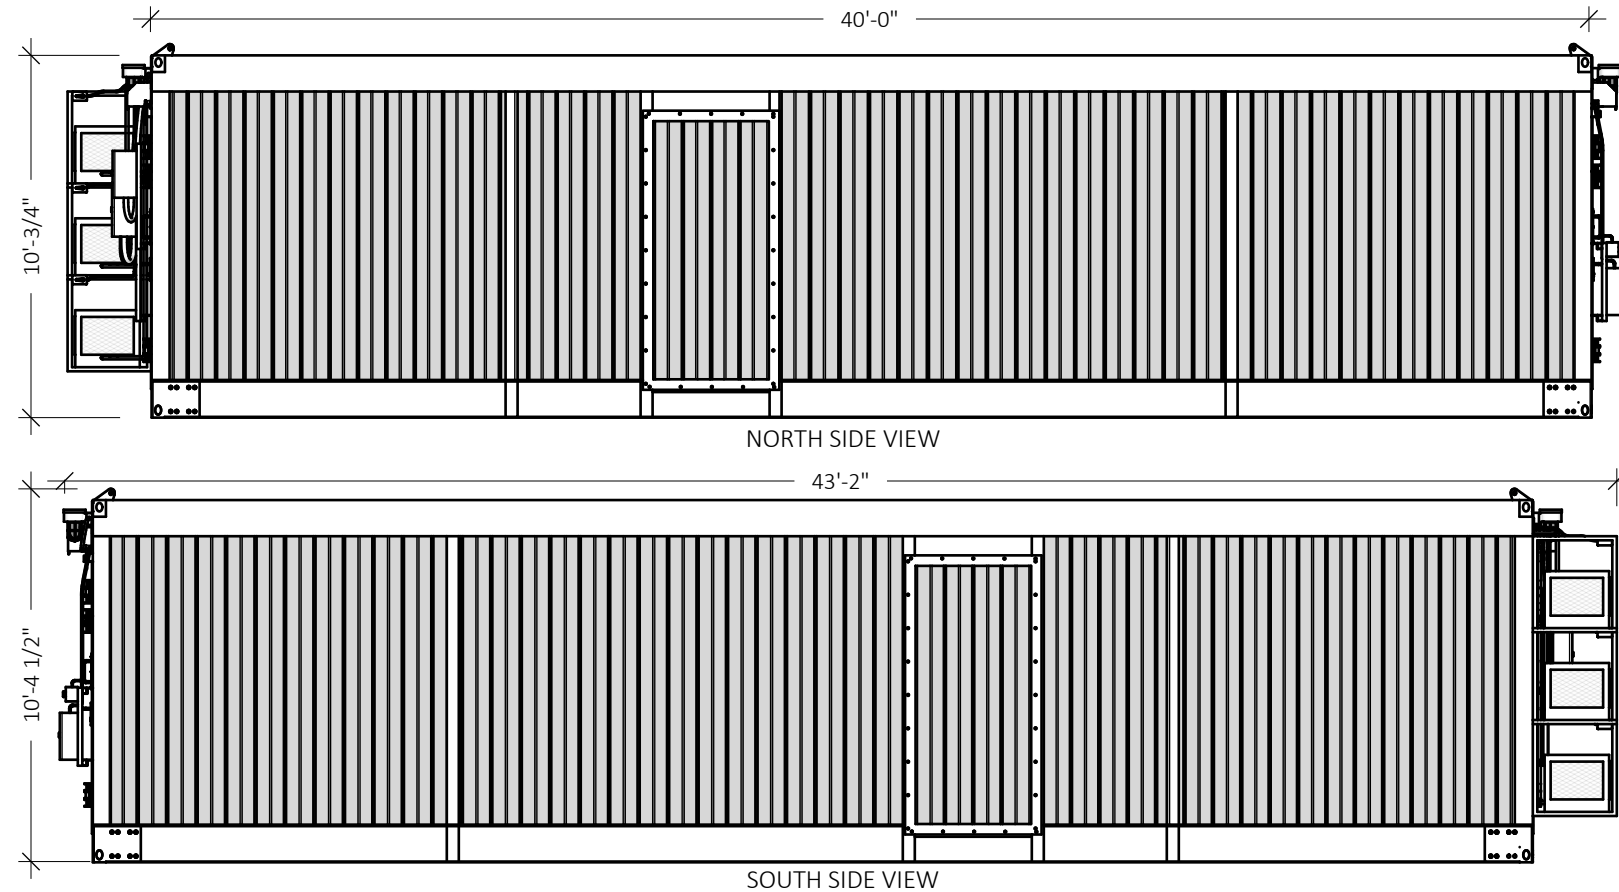


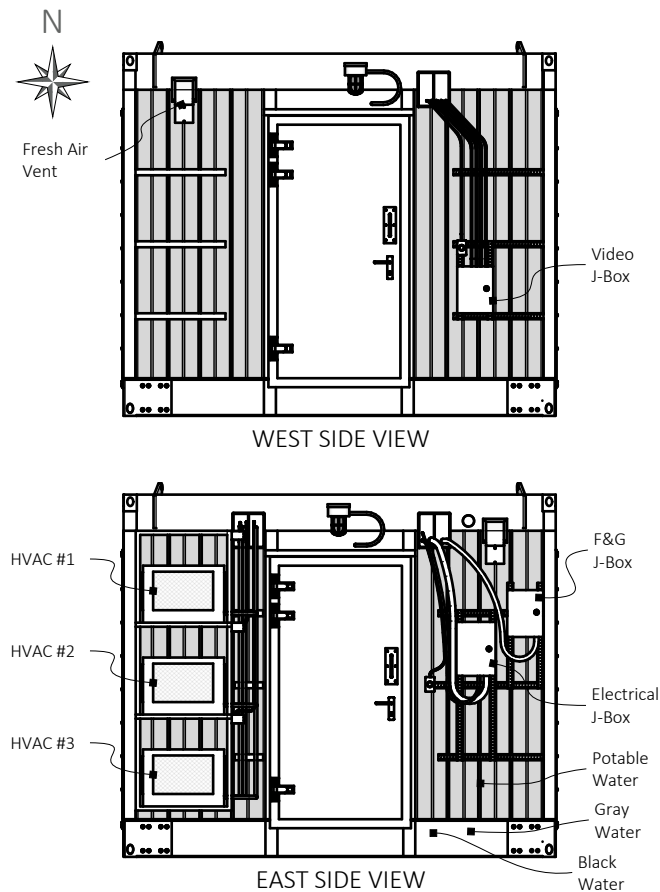


FURNISHINGS SCHEDULE		
MARK	QTY	DESCRIPTION
①	8	Bunk Shelf
②	12	Single Locker
③	4	Bunk Beds
④	2	Water Heater
⑤	3	Vanity Cabinet with Sink & Mirror
⑥	3	Custom Stainless Steel Shower
⑦	3	Toilet with Upper Cabinet
⑧	2	Desk with Chair(s)
⑨	1	File Cabinet
⑩	1	TV Entertainment Area


FIRE & GAS SCHEDULE		
MARK	QTY	DESCRIPTION
①	1	Fire & Gas Panel
②	2	Fire Extinguisher
③	3	Gas Detector
④	3	Smoke Detector
⑤	5	Thermal Detector

DOOR SCHEDULE		
MARK	QTY	DESCRIPTION
A	2	3-0 x 6-8 Exterior H-60
B	2	2-8 x 6-8 Mild Steel Class-B
C	3	2-0 x 6-8 Mild Steel Class-B

ELECTRICAL/HVAC SCHEDULE		
MARK	QTY	DESCRIPTION
⚡	1	Electrical Panel 120/240V 3-ph (Class 1 Div 2)
⚡	3	HVAC Condenser Unit (Class 1 div 2)
⚡	3	HVAC Air Handler Unit

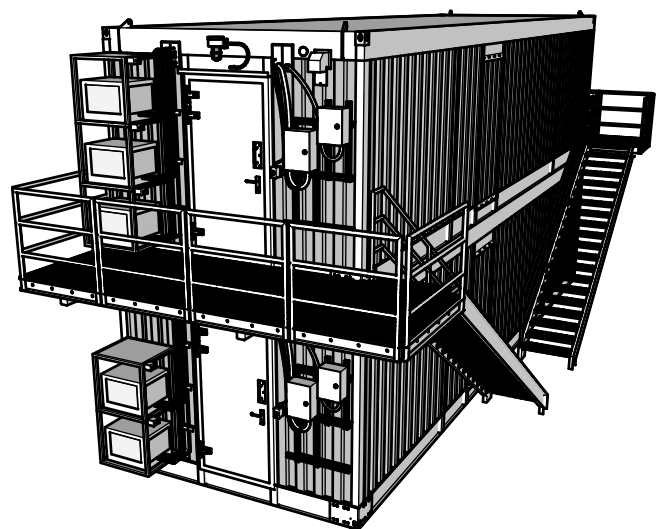

ISOMETRIC STACKED VIEW

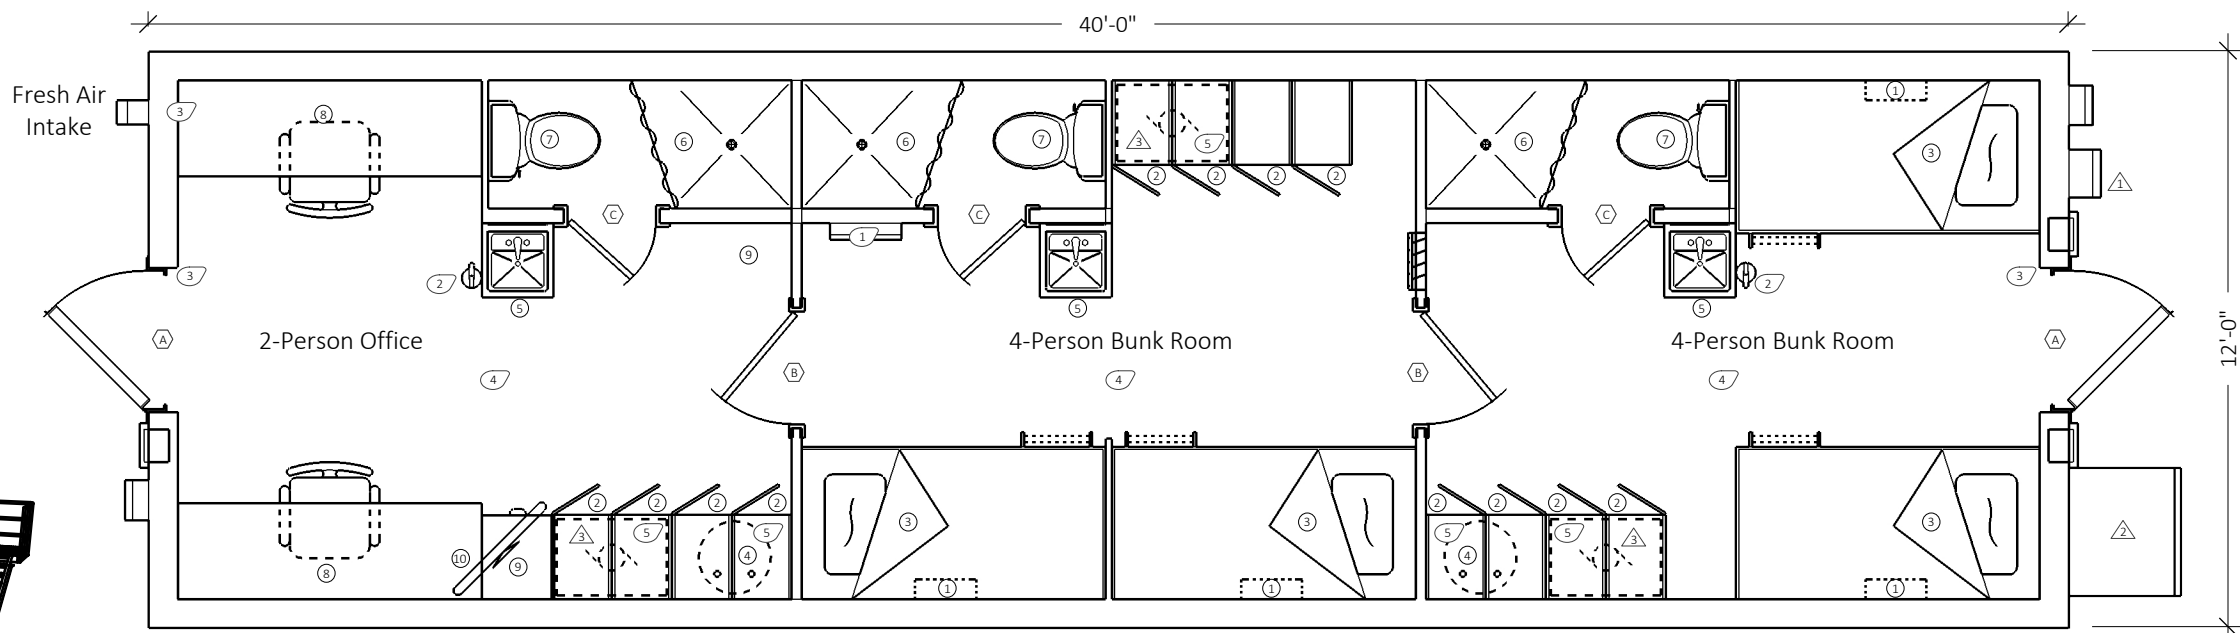

APPROVED (PROCEED AS IS)	☐
APPROVED AS NOTED (REVISE AND RESUBMIT)	☐
REJECTED (DO NOT PROCEED, RESUBMIT)	☐
FOR INFORMATION ONLY	☒
Date:	
Customer Signature	

REVISION HISTORY		
REV	DATE	DESCRIPTION



Gulf Land Structures, LLC
PO Box 52605
Lafayette, LA 70505-2605
4100 Cameron Street
Lafayette, LA 70506
(337) 993-9858

Designed By:	GLS	Date:	06/21/14
Drawn By:	KED	Date:	04/15/17
GLS Quote:		Date:	



GLS RENTALS
DEPARTMENT



12' x 40' ABS H-60 Steel Building
8-Person Sleeper/1-Person Office
General Arrangement

Page	G-1.0
REV	A