
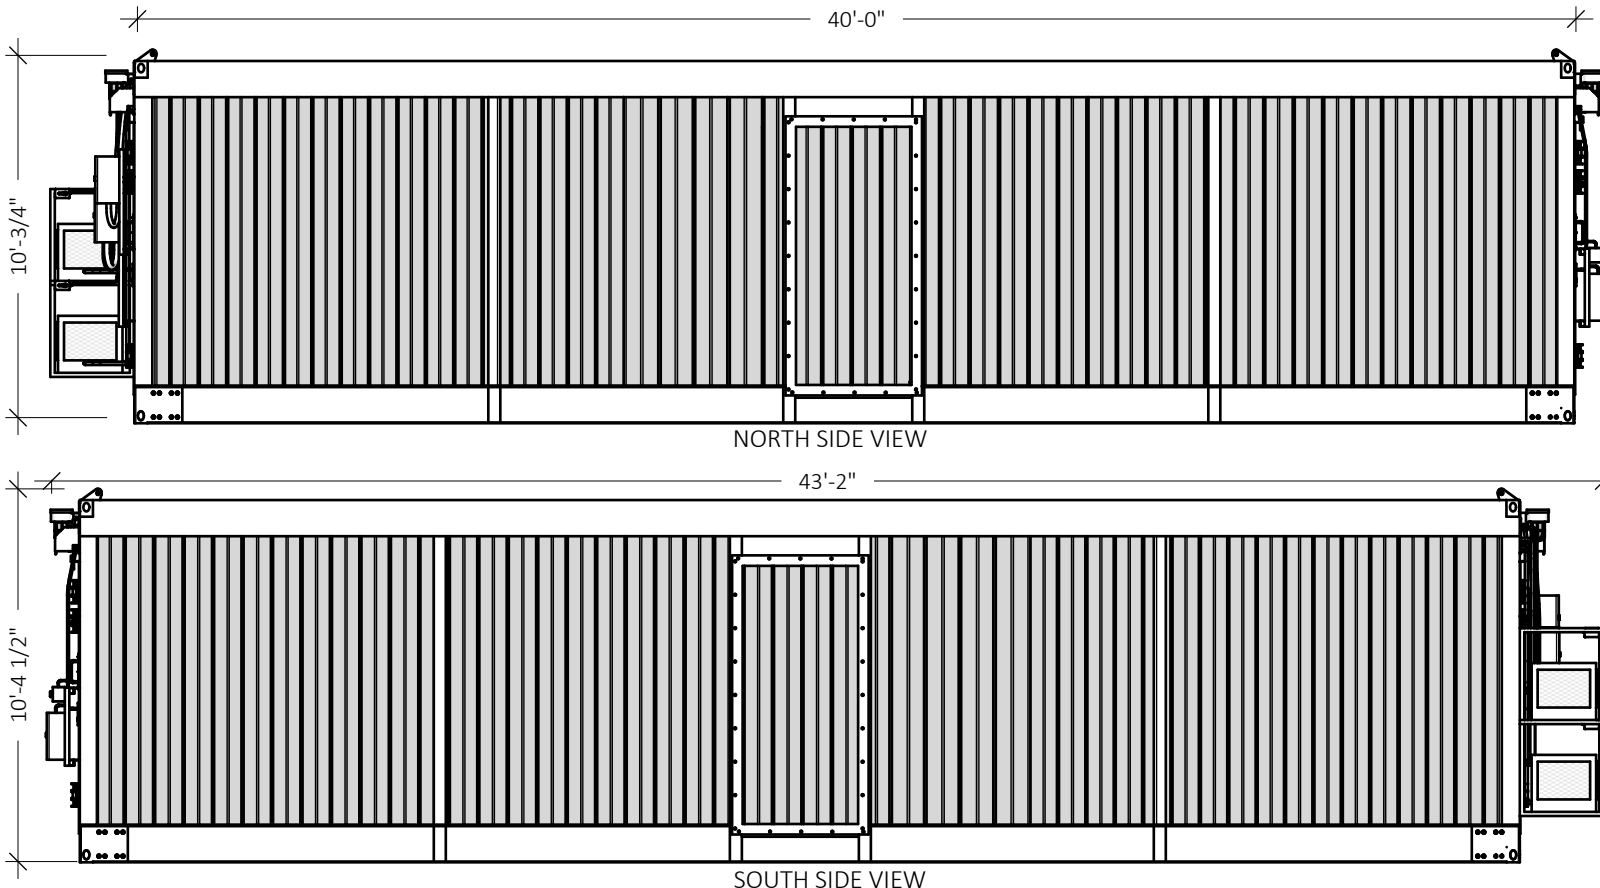


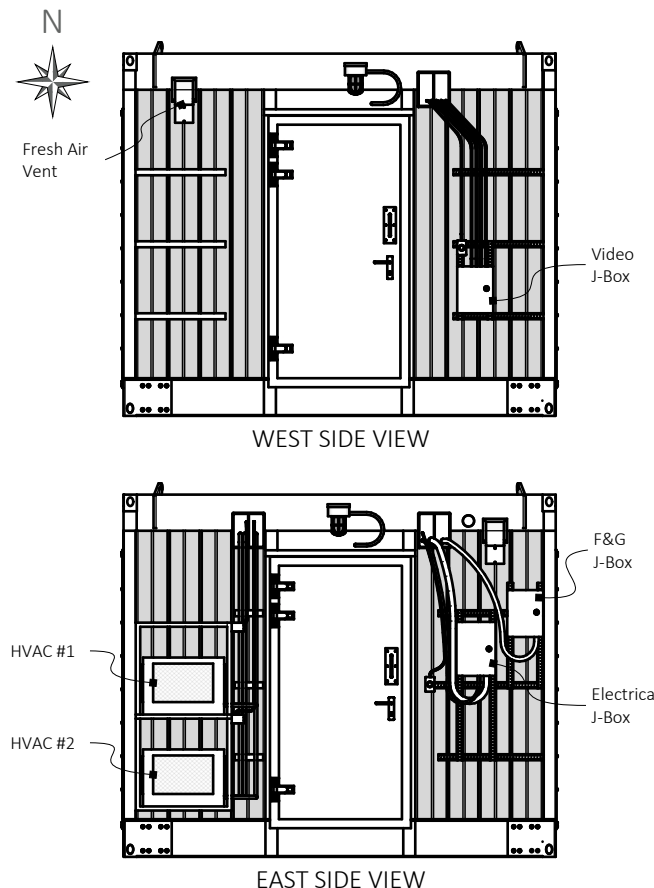


FURNISHINGS SCHEDULE		
MARK	QTY	DESCRIPTION
①	1	Snack Bar with Upper Shelf and Chairs
②	1	Warm Food Table
③	1	Cold Food Table
④	1	Ice Maker
⑤	1	Glass Door Refrigerator
⑥	1	Glass Door Freezer
⑦	1	Coffee Station with Microwave
⑧	6	Dining Table and Chairs


FIRE & GAS SCHEDULE		
MARK	QTY	DESCRIPTION
①	1	Fire & Gas Panel
②	3	Fire Extinguisher
③	3	Gas Detector
④	2	Smoke Detector
⑤	3	Thermal Detector

DOOR SCHEDULE		
MARK	QTY	DESCRIPTION
A	2	3-0 x 6-8 Exterior H-60

ELECTRICAL/HVAC SCHEDULE		
MARK	QTY	DESCRIPTION
①	1	Electrical Panel 120/240V 3-ph (Class 1 Div 2)
②	2	HVAC Condenser Unit (Class 1 div 2)
③	2	HVAC Air Handler Unit

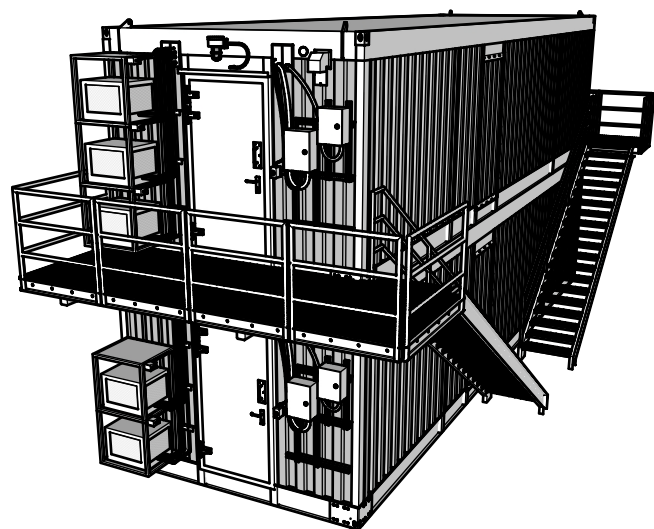

ISOMETRIC STACKED VIEW

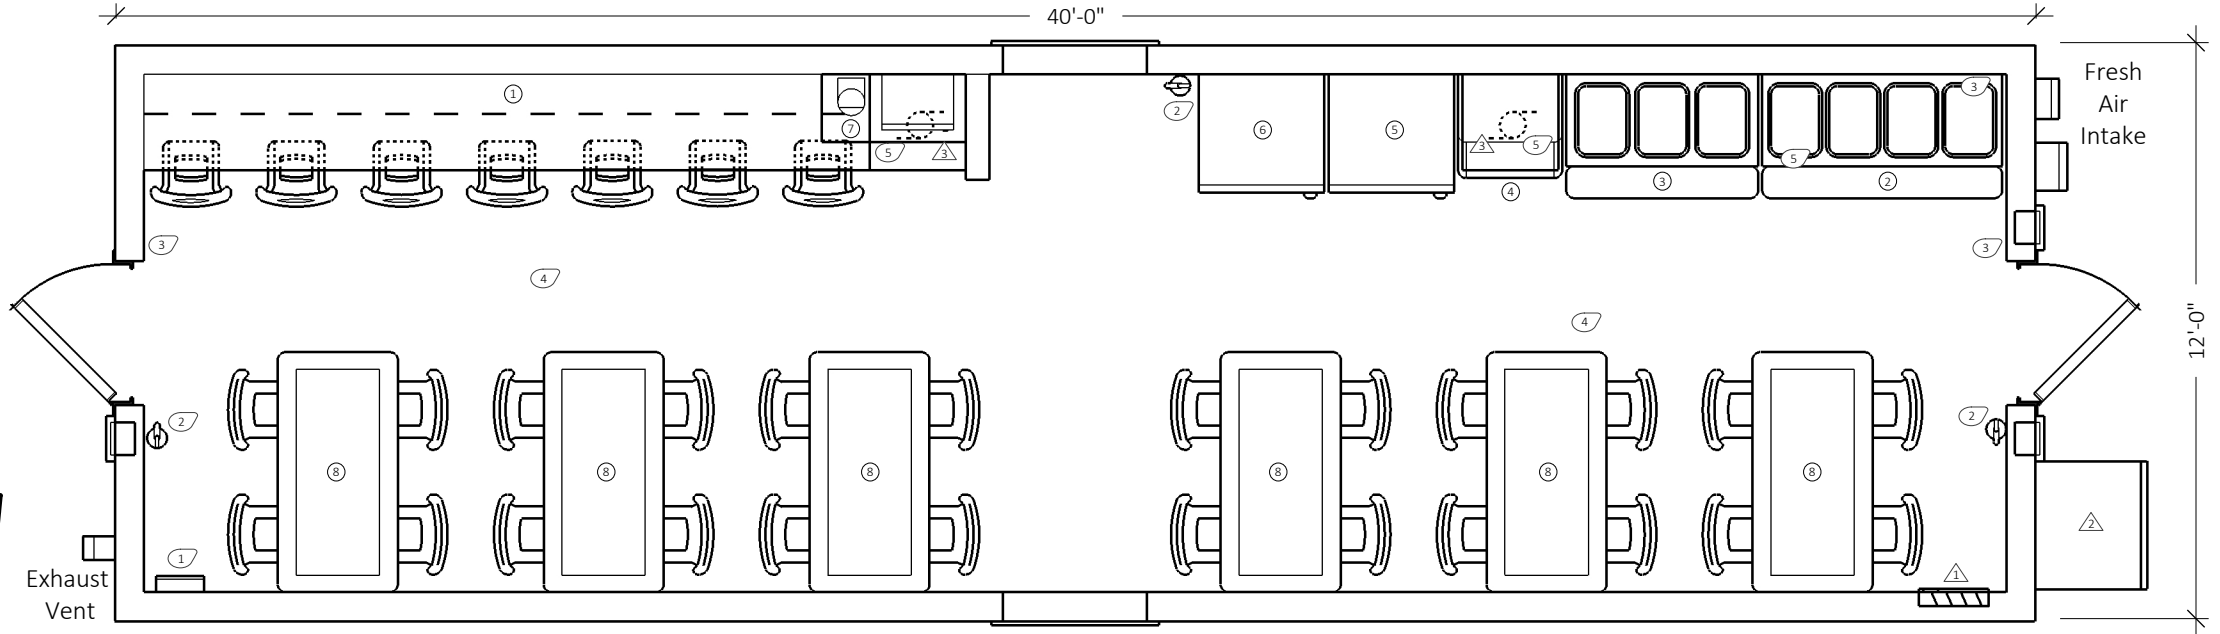

APPROVED (PROCEED AS IS) ☐

APPROVED AS NOTED (REVISE AND RESUBMIT) ☐

REJECTED (DO NOT PROCEED, RESUBMIT) ☐

FOR INFORMATION ONLY ☒

Date: _____

Customer Signature _____

REVISION HISTORY		
REV	DATE	DESCRIPTION



Gulf Land Structures, LLC
PO Box 52605
Lafayette, LA 70505-2605
4100 Cameron Street
Lafayette, LA 70506
(337) 993-9858

Designed By:	GLS	Date:	06/21/14
Drawn By:	KED	Date:	04/21/16
GLS Quote:		Date:	



GLS RENTALS
DEPARTMENT



12' x 40' ABS H-60 Steel Building
30-Person Diner
General Arrangement

Page	G-1.0
REV	A