




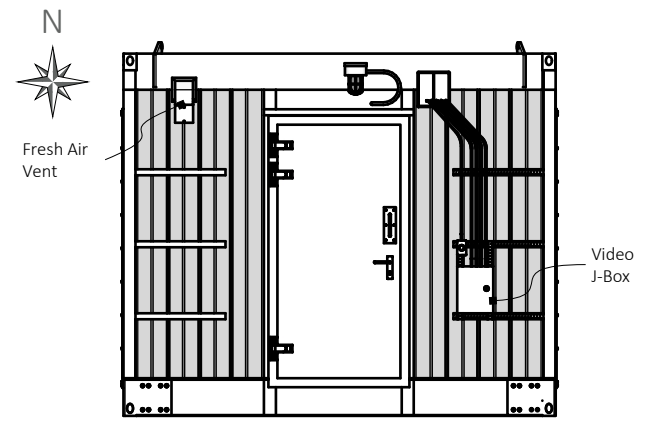


WEST SIDE VIEW

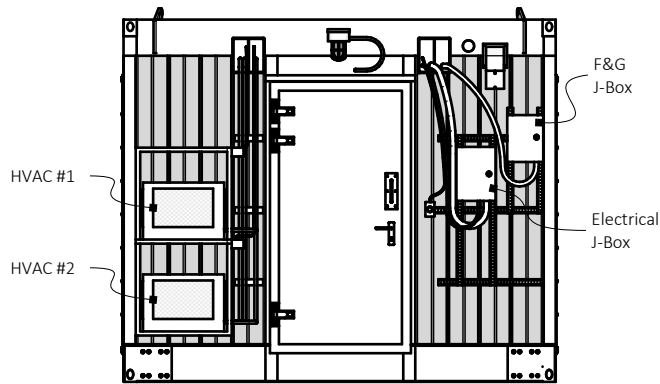

EAST SIDE VIEW

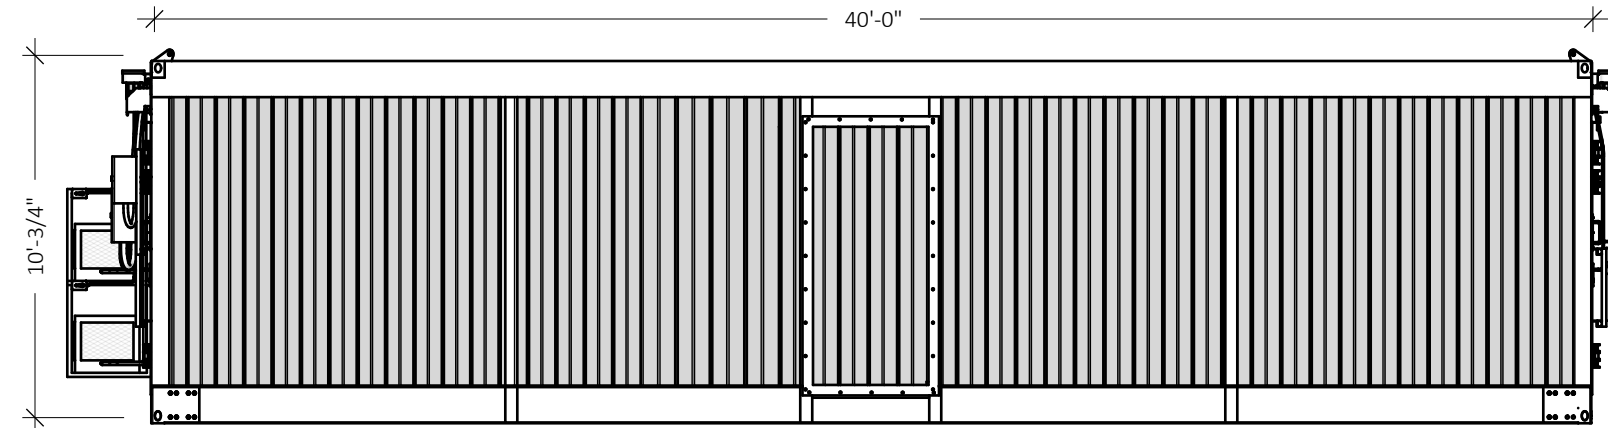

NORTH SIDE VIEW

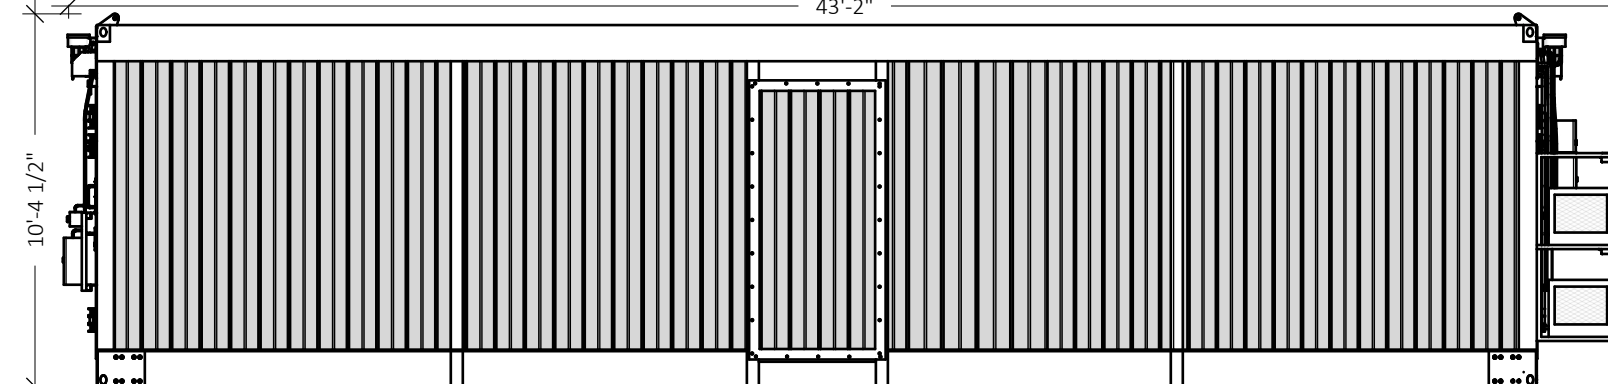


SOUTH SIDE VIEW

FURNISHINGS SCHEDULE		
MARK	QTY	DESCRIPTION
①	10	Office Desktop
②	10	Office Chair
③	20	File Cabinet (Under Desktop)
④	1	Coffee Station with Microwave


FIRE & GAS SCHEDULE		
MARK	QTY	DESCRIPTION
①	1	Fire & Gas Panel
②	2	Fire Extinguisher
③	3	Gas Detector
④	2	Smoke Detector
⑤	2	Thermal Detector

DOOR SCHEDULE		
MARK	QTY	DESCRIPTION
A	2	3-0 x 6-8 Exterior H-60

ELECTRICAL/HVAC SCHEDULE		
MARK	QTY	DESCRIPTION
△	1	Electrical Panel 120/240V 3-ph (Class 1 Div 2)
△	2	HVAC Condenser Unit (Class 1 div 2)
△	2	HVAC Air Handler Unit

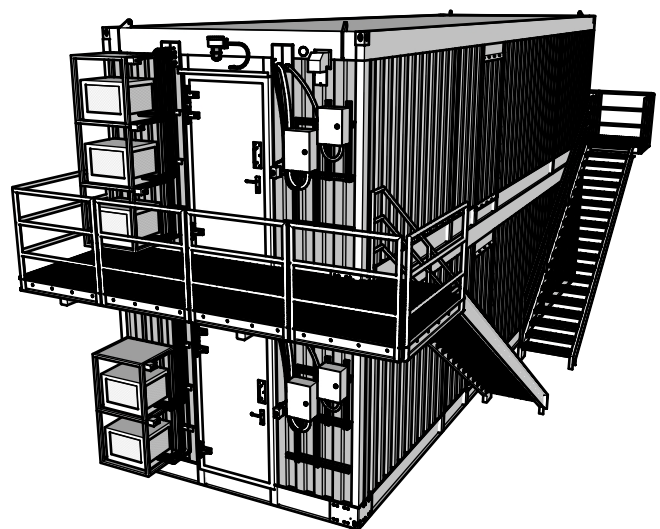

ISOMETRIC STACKED VIEW

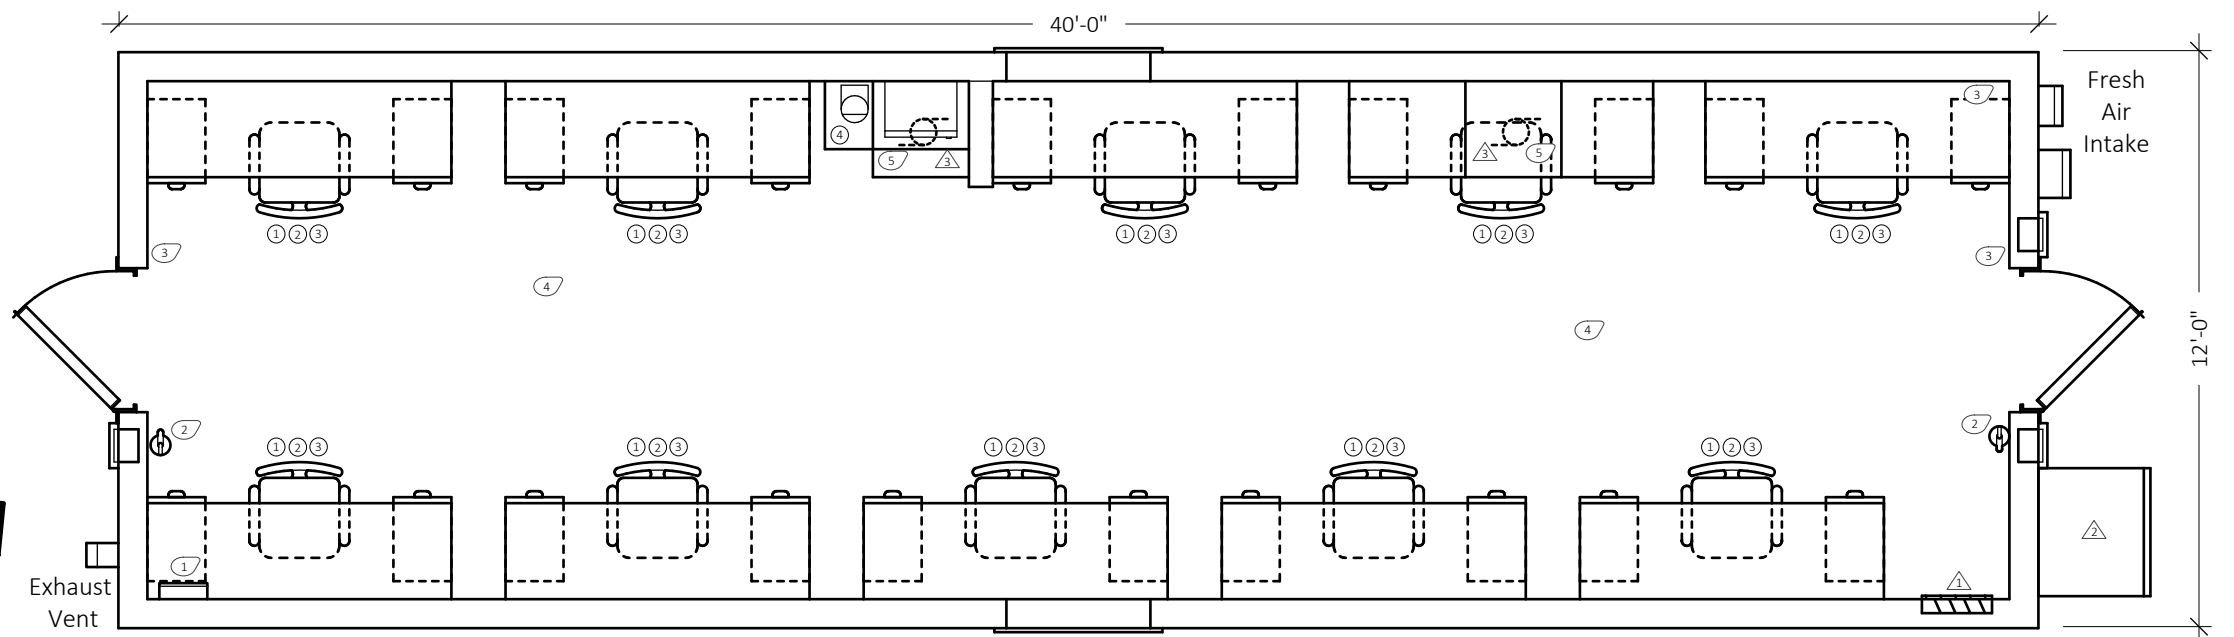

APPROVED (PROCEED AS IS)	☐
APPROVED AS NOTED (REVISE AND RESUBMIT)	☐
REJECTED (DO NOT PROCEED, RESUBMIT)	☐
FOR INFORMATION ONLY	☒
Date:	
Customer Signature	

REVISION HISTORY		
REV	DATE	DESCRIPTION



Gulf Land Structures, LLC
PO Box 52605
Lafayette, LA 70505-2605
4100 Cameron Street
Lafayette, LA 70506
(337) 993-9858

Designed By:	GLS	Date:	06/21/14
Drawn By:	KED	Date:	05/12/16
GLS Quote:		Date:	



GLS RENTALS
DEPARTMENT



12' x 40' ABS H-60 Steel Building
30-Person Diner Conversion to 10-Person Office
General Arrangement

Page	G-1.0
REV	A