
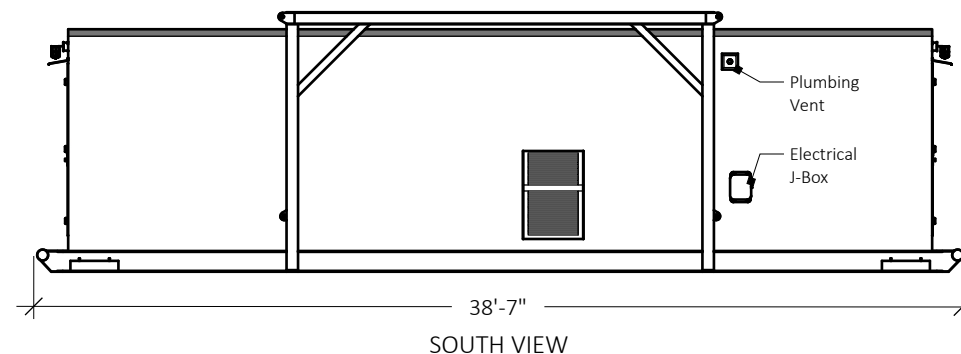
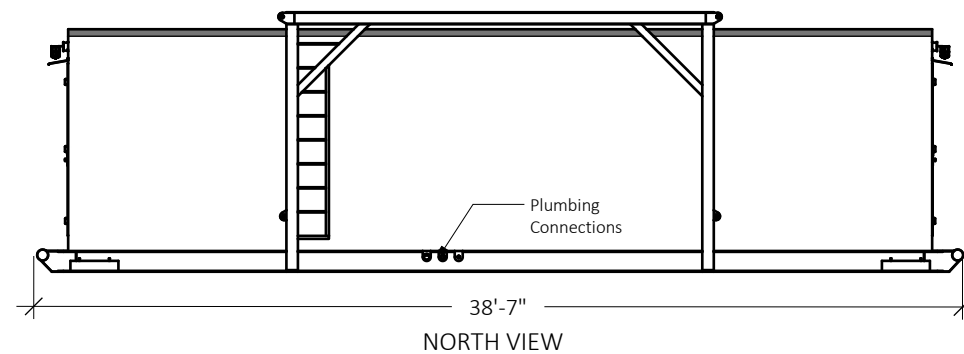
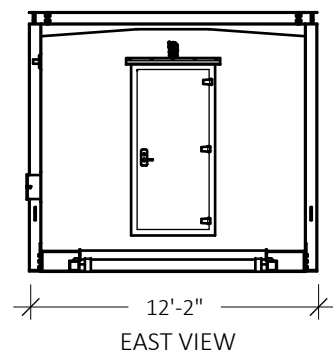


ELECTRICAL/HVAC SCHEDULE		
MARK	QTY	DESCRIPTION
1	1	Electrical Panel 120/240V 1-ph (Non-Classified)
2	1	HVAC Unit (Non-Classified)

FURNISHINGS SCHEDULE		
MARK	QTY	DESCRIPTION
①	8	Bunk Shelf
②	4	Double Stack Lockers
③	4	Bunk Beds
④	1	Water Heater
⑤	1	Vanity Cabinet with Sink & Mirror
⑥	2	Shower 36"
⑦	2	Toilet with Upper Shelf
⑧	4	Desk and Chair
⑨	2	Under Counter File Cabinet
⑩	1	Stack Washer / Dryer

[illegible]

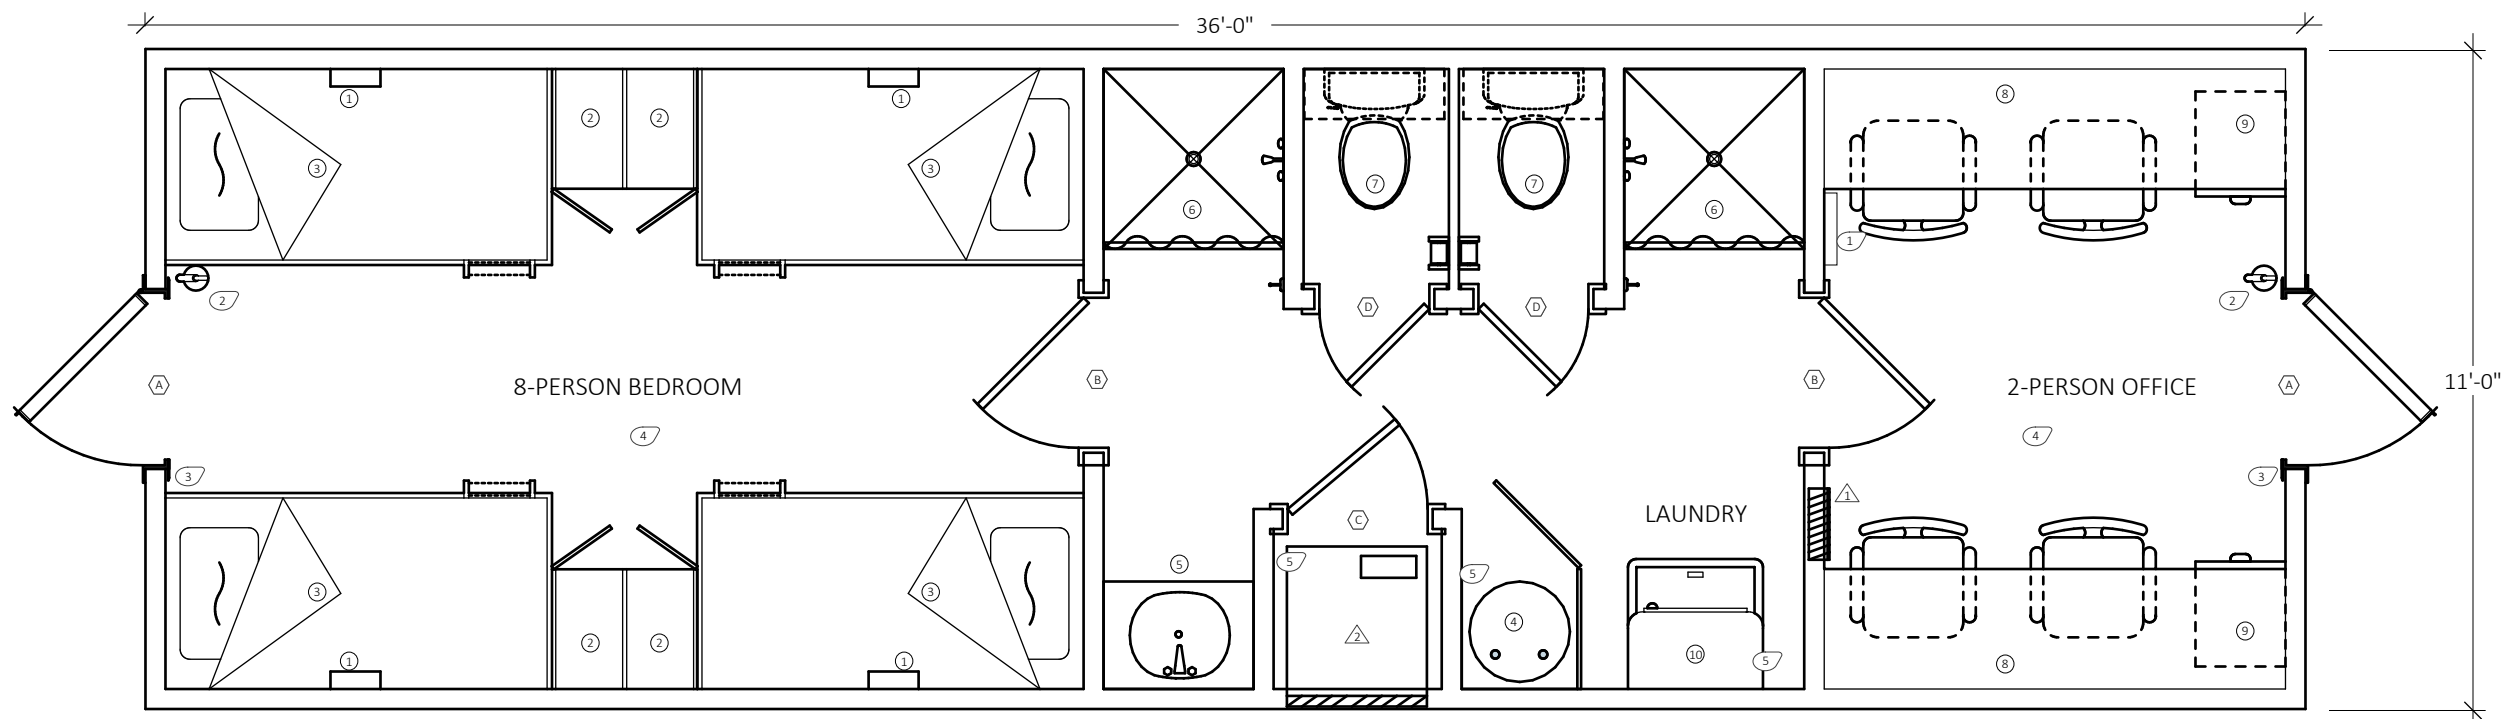

Gulf Land Structures, LLC

PO Box 52605
Lafayette, LA 70505-2605

4100 Cameron Street
Lafayette, LA 70506



**GLS RENTALS
DEPARTMENT**

Designed By: KED		Date: 06/21/07		11' x 36' Fiberglass Building 8-Person Sleeper / 4-Person Office / Laundry ----- General Arrangement	Page G-1.0 REV A
Drawn By: KED		Date: 03/23/16			
GLS Quote:		Date:			